


This drawing shall not be scaled.
Work from the dimensions shown in the drawing or given in relevant specifications

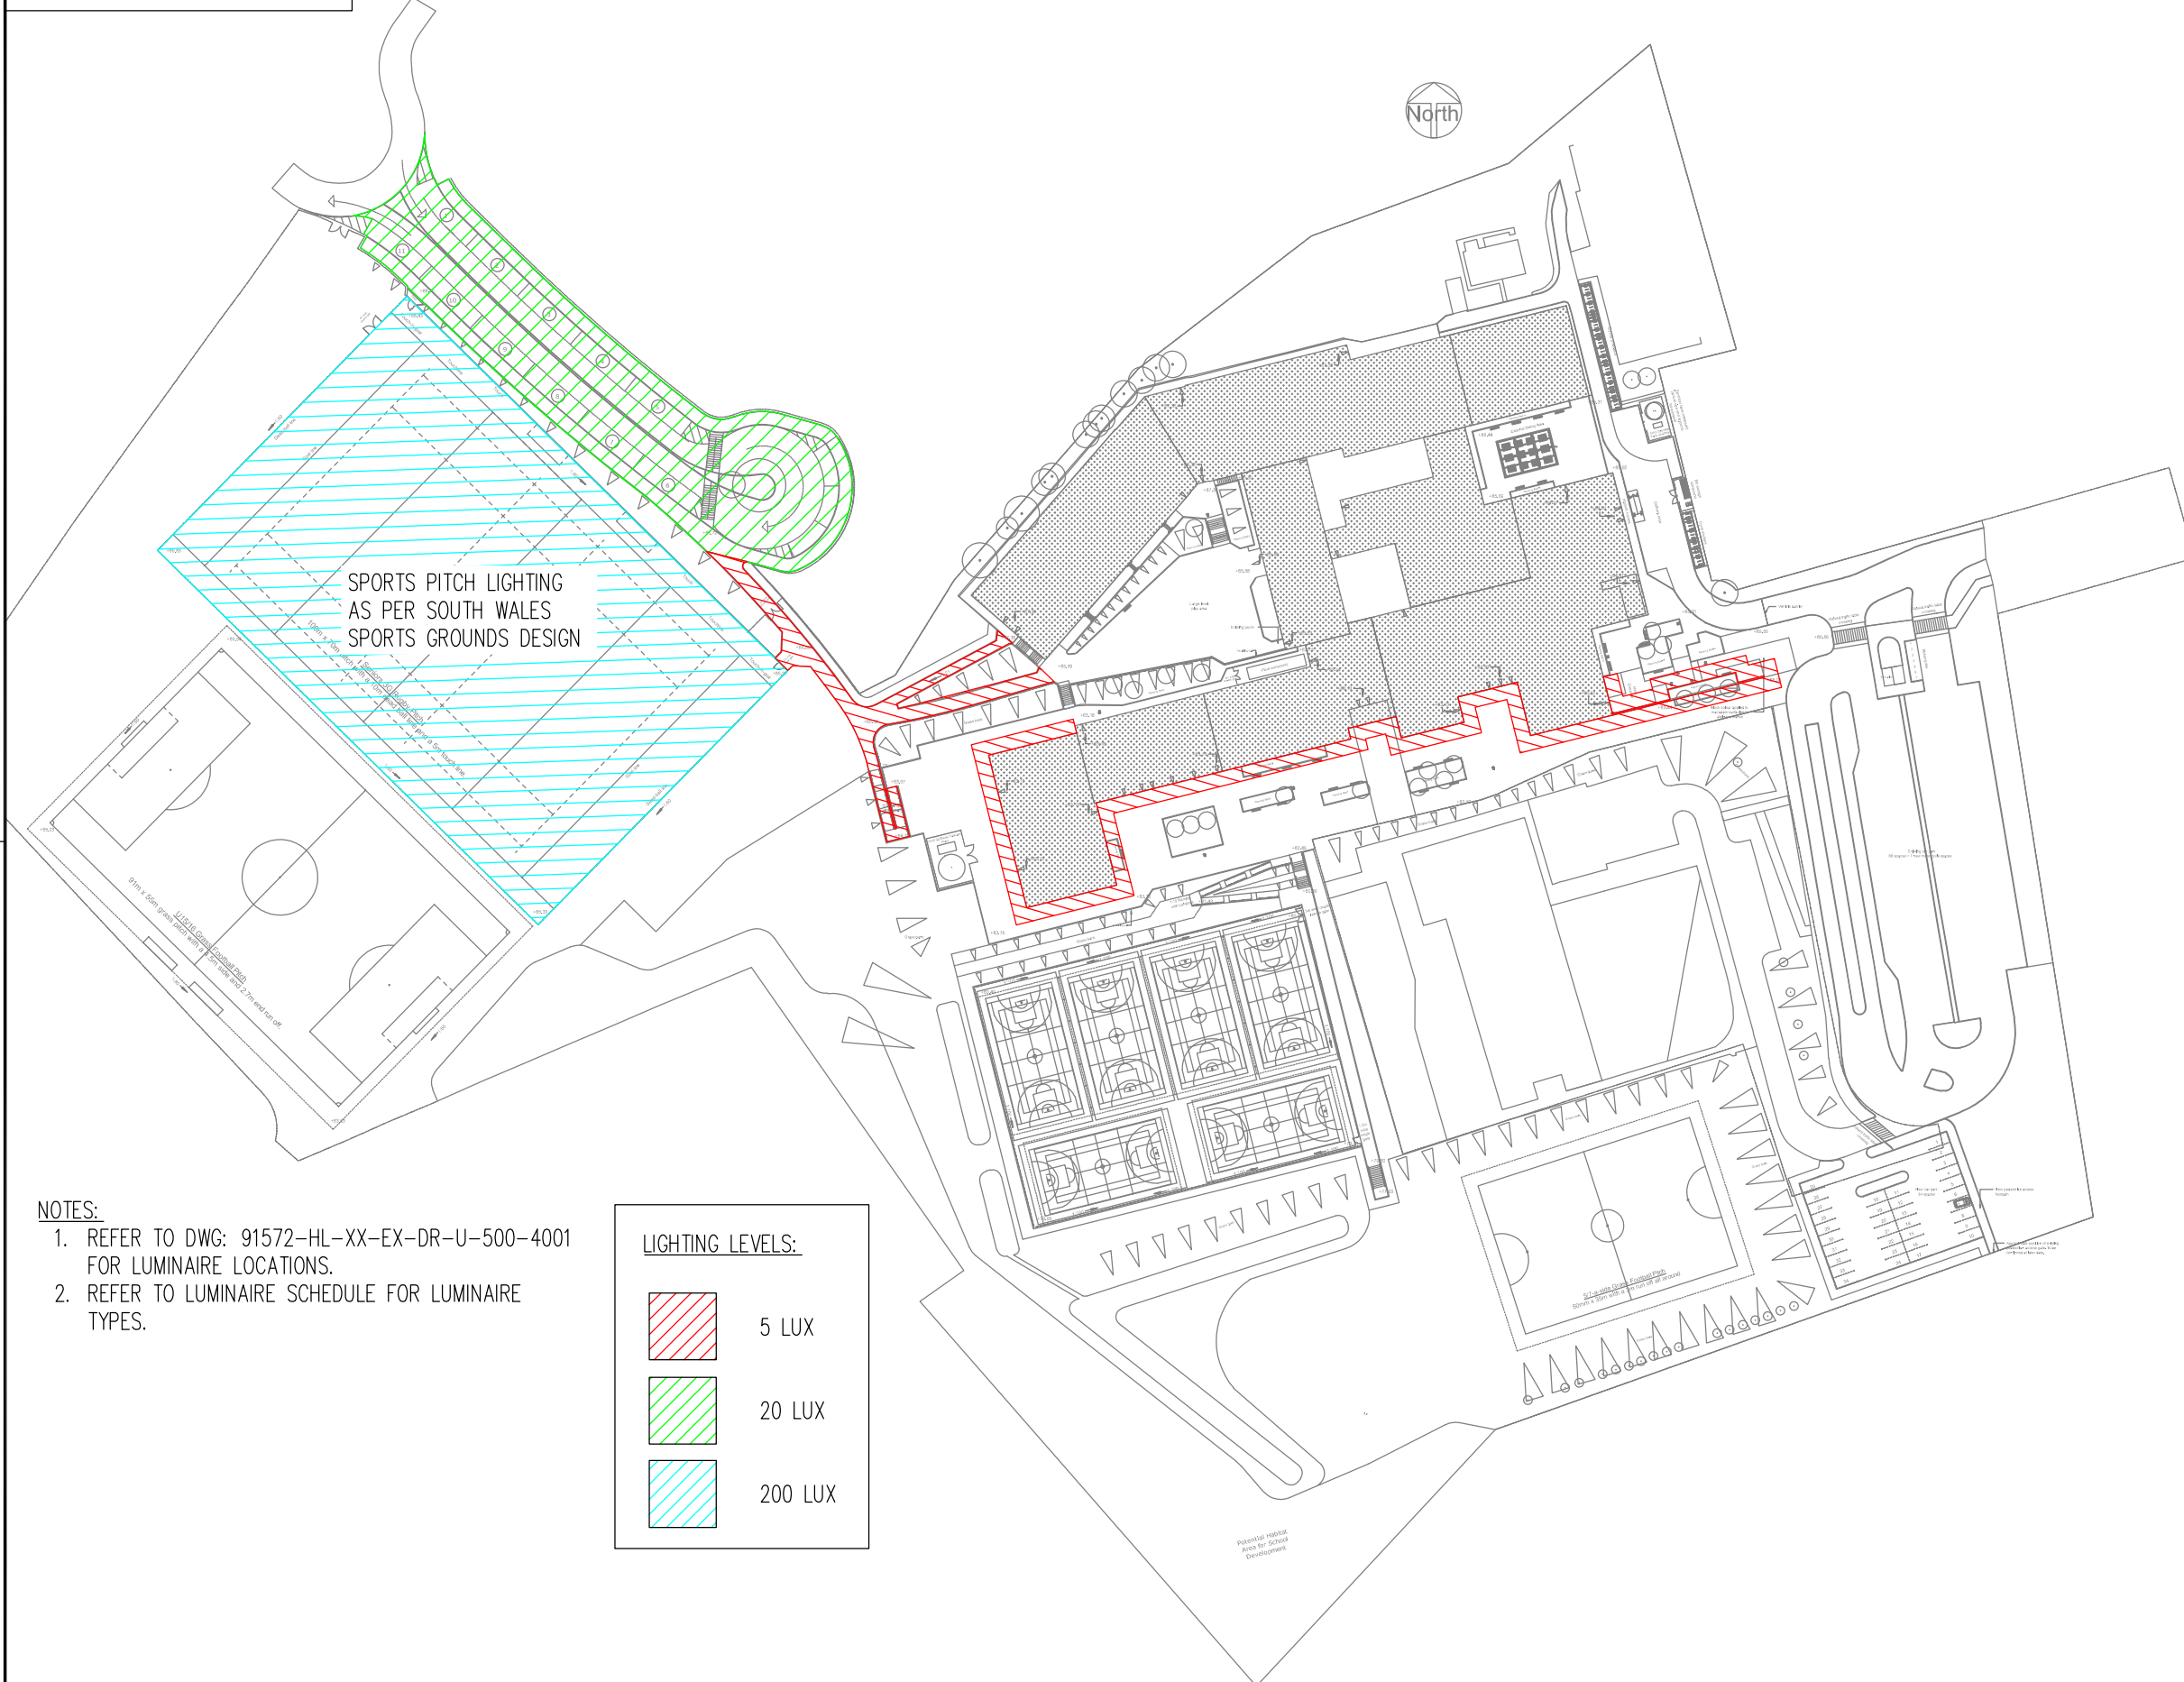

- NOTES:**
- REFER TO DWG: 91572-HL-XX-EX-DR-U-500-4001 FOR LUMINAIRE LOCATIONS.
 - REFER TO LUMINAIRE SCHEDULE FOR LUMINAIRE TYPES.

LIGHTING LEVELS:

	5 LUX
	20 LUX
	200 LUX

CDM Regulations:
In addition to any information included in this drawing or the model from which it is derived, refer also to the project CDM Risk Register for information on residual risks.

- General Notes:**
- The drawing does not necessarily show all the information needed to interpret the design intent or the construction details.
 - The drawing contains information from more than one source and must be read in conjunction with all relevant specifications.
 - Any apparent drafting errors and differences between other drawings and specifications shall be brought to our attention.

Project Notes:

--	--	--	--	--	--

Index	Description	Designed	Reviewed	Authorised	Date
-------	-------------	----------	----------	------------	------

REVISIONS:



ARCHITECT:
AUSTIN-SMITH:LORD

CLIENT:
VALE OF GLAMORGAN

PROJECT TITLE:
YSGOL GYMRAEG BRO MORGANNWG

DRAWING TITLE:
EXTERNAL LIGHTING STRATEGY

TENDER ISSUE

PERSON RESPONSIBLE FOR:

Design: IG	Review: RG	Authorising Issue: AMT
----------------------	----------------------	----------------------------------

Project No: 09/91572	Date: APR 19	Scale @ A3: NTS @ A3
--------------------------------	------------------------	--------------------------------

DRAWING NUMBER: 91572-HL-XX-EX-DR-E-630-3001	Revision: T00
--	-------------------------