

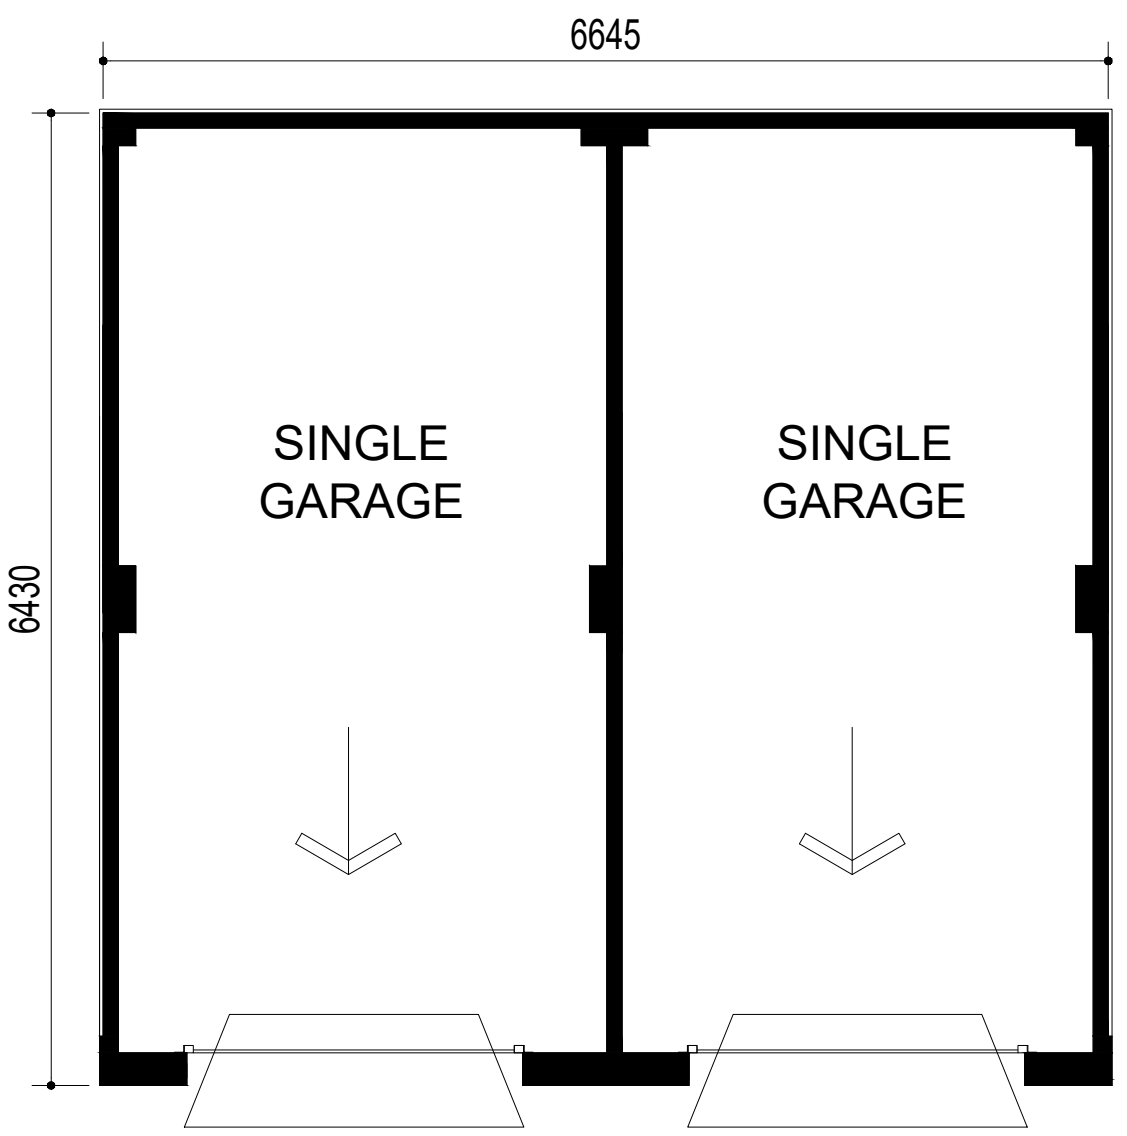
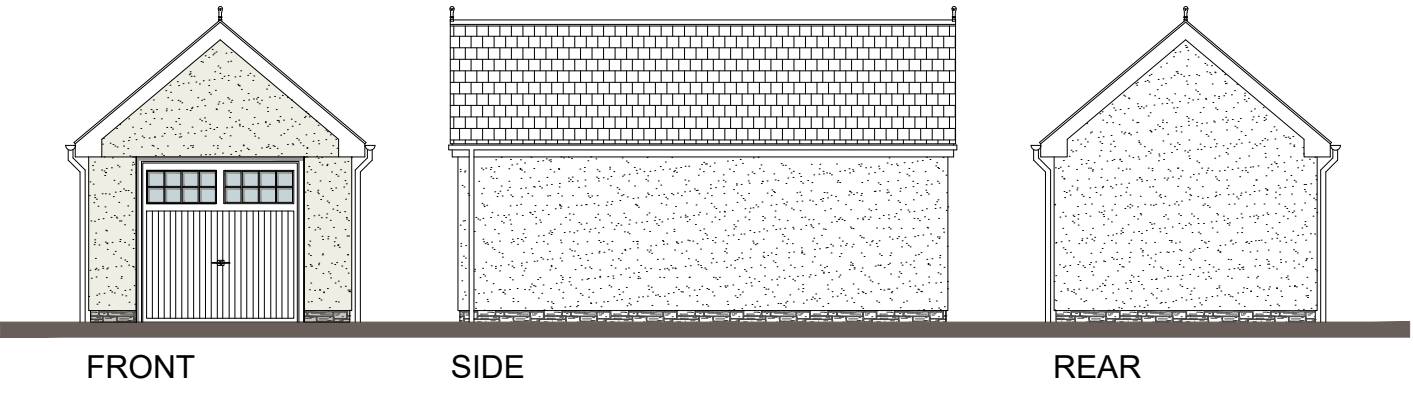


Important Notice
 These particulars are for illustration only. We operate a policy of continuous product development and individual features such as windows, garages and elevation treatments may vary from time to time as may heating and electrical layouts. Consequently these particulars should be treated as general guidance only and cannot be relied upon as accurately describing any of the Specified Matters prescribed by any Order made under the Property Misdescriptions Act 1991. Nor do they constitute a contract, part of a contract or a warranty.

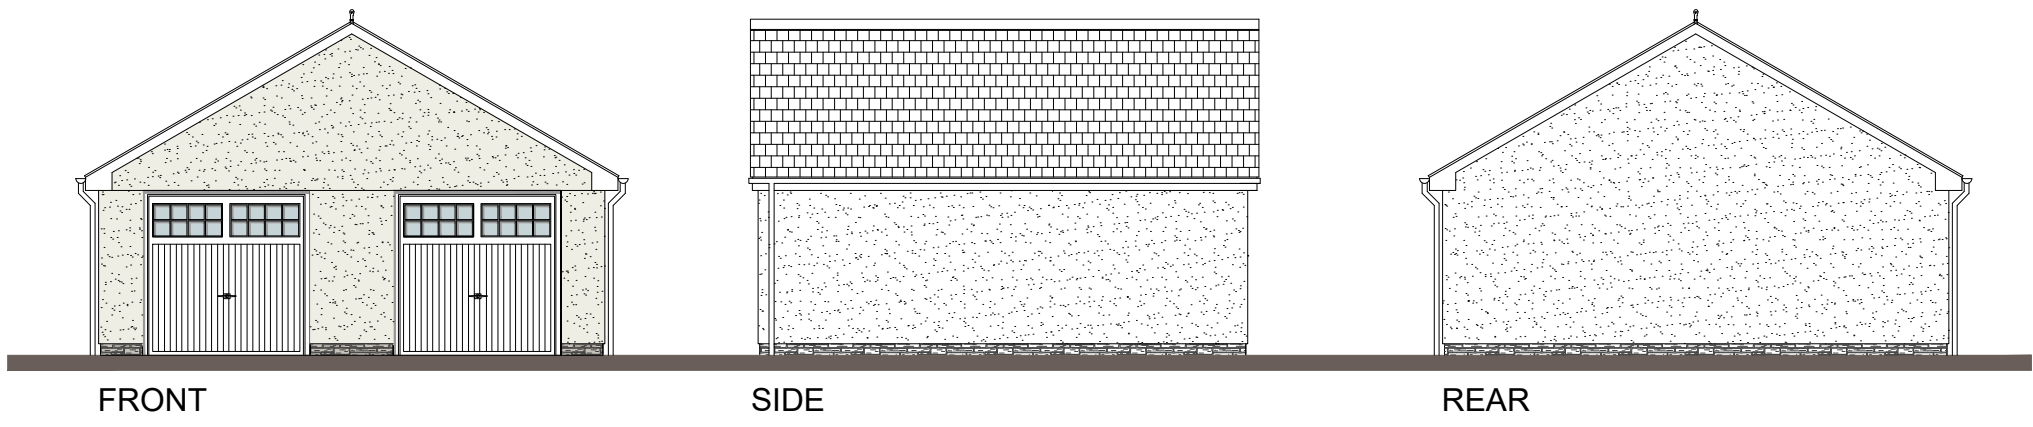

FLOOR PLAN

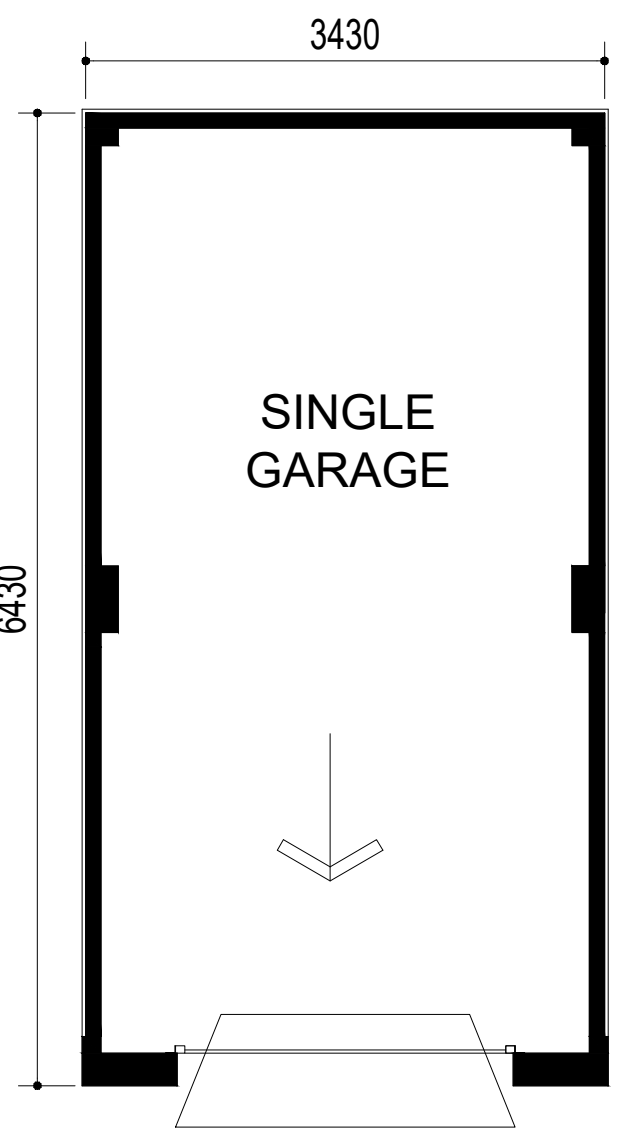

FLOOR PLAN

EXTERNAL FINISHES

- EXT WALLS**
White render.
- ROOF TILES**
Marley Modern.
Colour - Slate Grey
- RAINWATER GOODS**
UPVc square gutters. - black
- VERGE**
Dry construction
- RIDGE**
Dry construction
- FASCIA**
White UPVc
- SOFFIT**
White UPVc

REV.	DESCRIPTION	DATE
CLIENT		
<i>The key to quality</i> Lewis Homes		
JOB TITLE		
Sandy Lane, Ystradowen		
DRAWING TITLE		
Garage Planning Drawings		
SCALE @ A3	DATE	DRAWN BY
1:100/1:50	February '24	RW
JOB NO.	DRAWING NO.	REVISION
1941	GAR-01	A

hammond
 ARCHITECTURAL LTD
 Melrose Court
 Melrose Hall
 Cypress Drive
 St. Mellons
 Cardiff CF3 0EG

t. 029 2077 6900
 f. 029 2079 9619
 e. info@hammond-ltd.co.uk

www.hammond-ltd.co.uk

© Hammond Architectural Limited 2024
 Figured dimensions must be taken in preference to scaled dimensions and any discrepancies are to be referred to Hammond Architectural Ltd. Contractors, subcontractors and suppliers must verify all dimensions on site before commencing any work or making any workshop drawings.