

Responsibility is not accepted for errors made by others in scaling from this drawing.
All construction information should be taken from figured dimensions only.

Legend


- Site boundary.
- - - Fence.
Refer to drawing SNPS-STL-XX-XX-DR-L-9004 Fencing and Security Plan for details.

Gates

- Pedestrian single gate.
- Site entrance vehicle gate.
- Pedestrian and/or maintenance double gate.

- R** Recycling bins.
- B** General waste bins.
- A** Accessible parking space.
- E** Electric charging space.
- Bollard.
Refer to drawing SNPS-STL-XX-XX-DR-L-9002 Hard Landscape Plan for details.
- New tree planting.
Refer to drawing SNPS-STL-XX-XX-DR-L-9003 Soft Landscape Plan for details.
- Existing trees to be retained to BS 5837:2012.

NOTE:
For levels and drainage information refer to engineers plans and details.

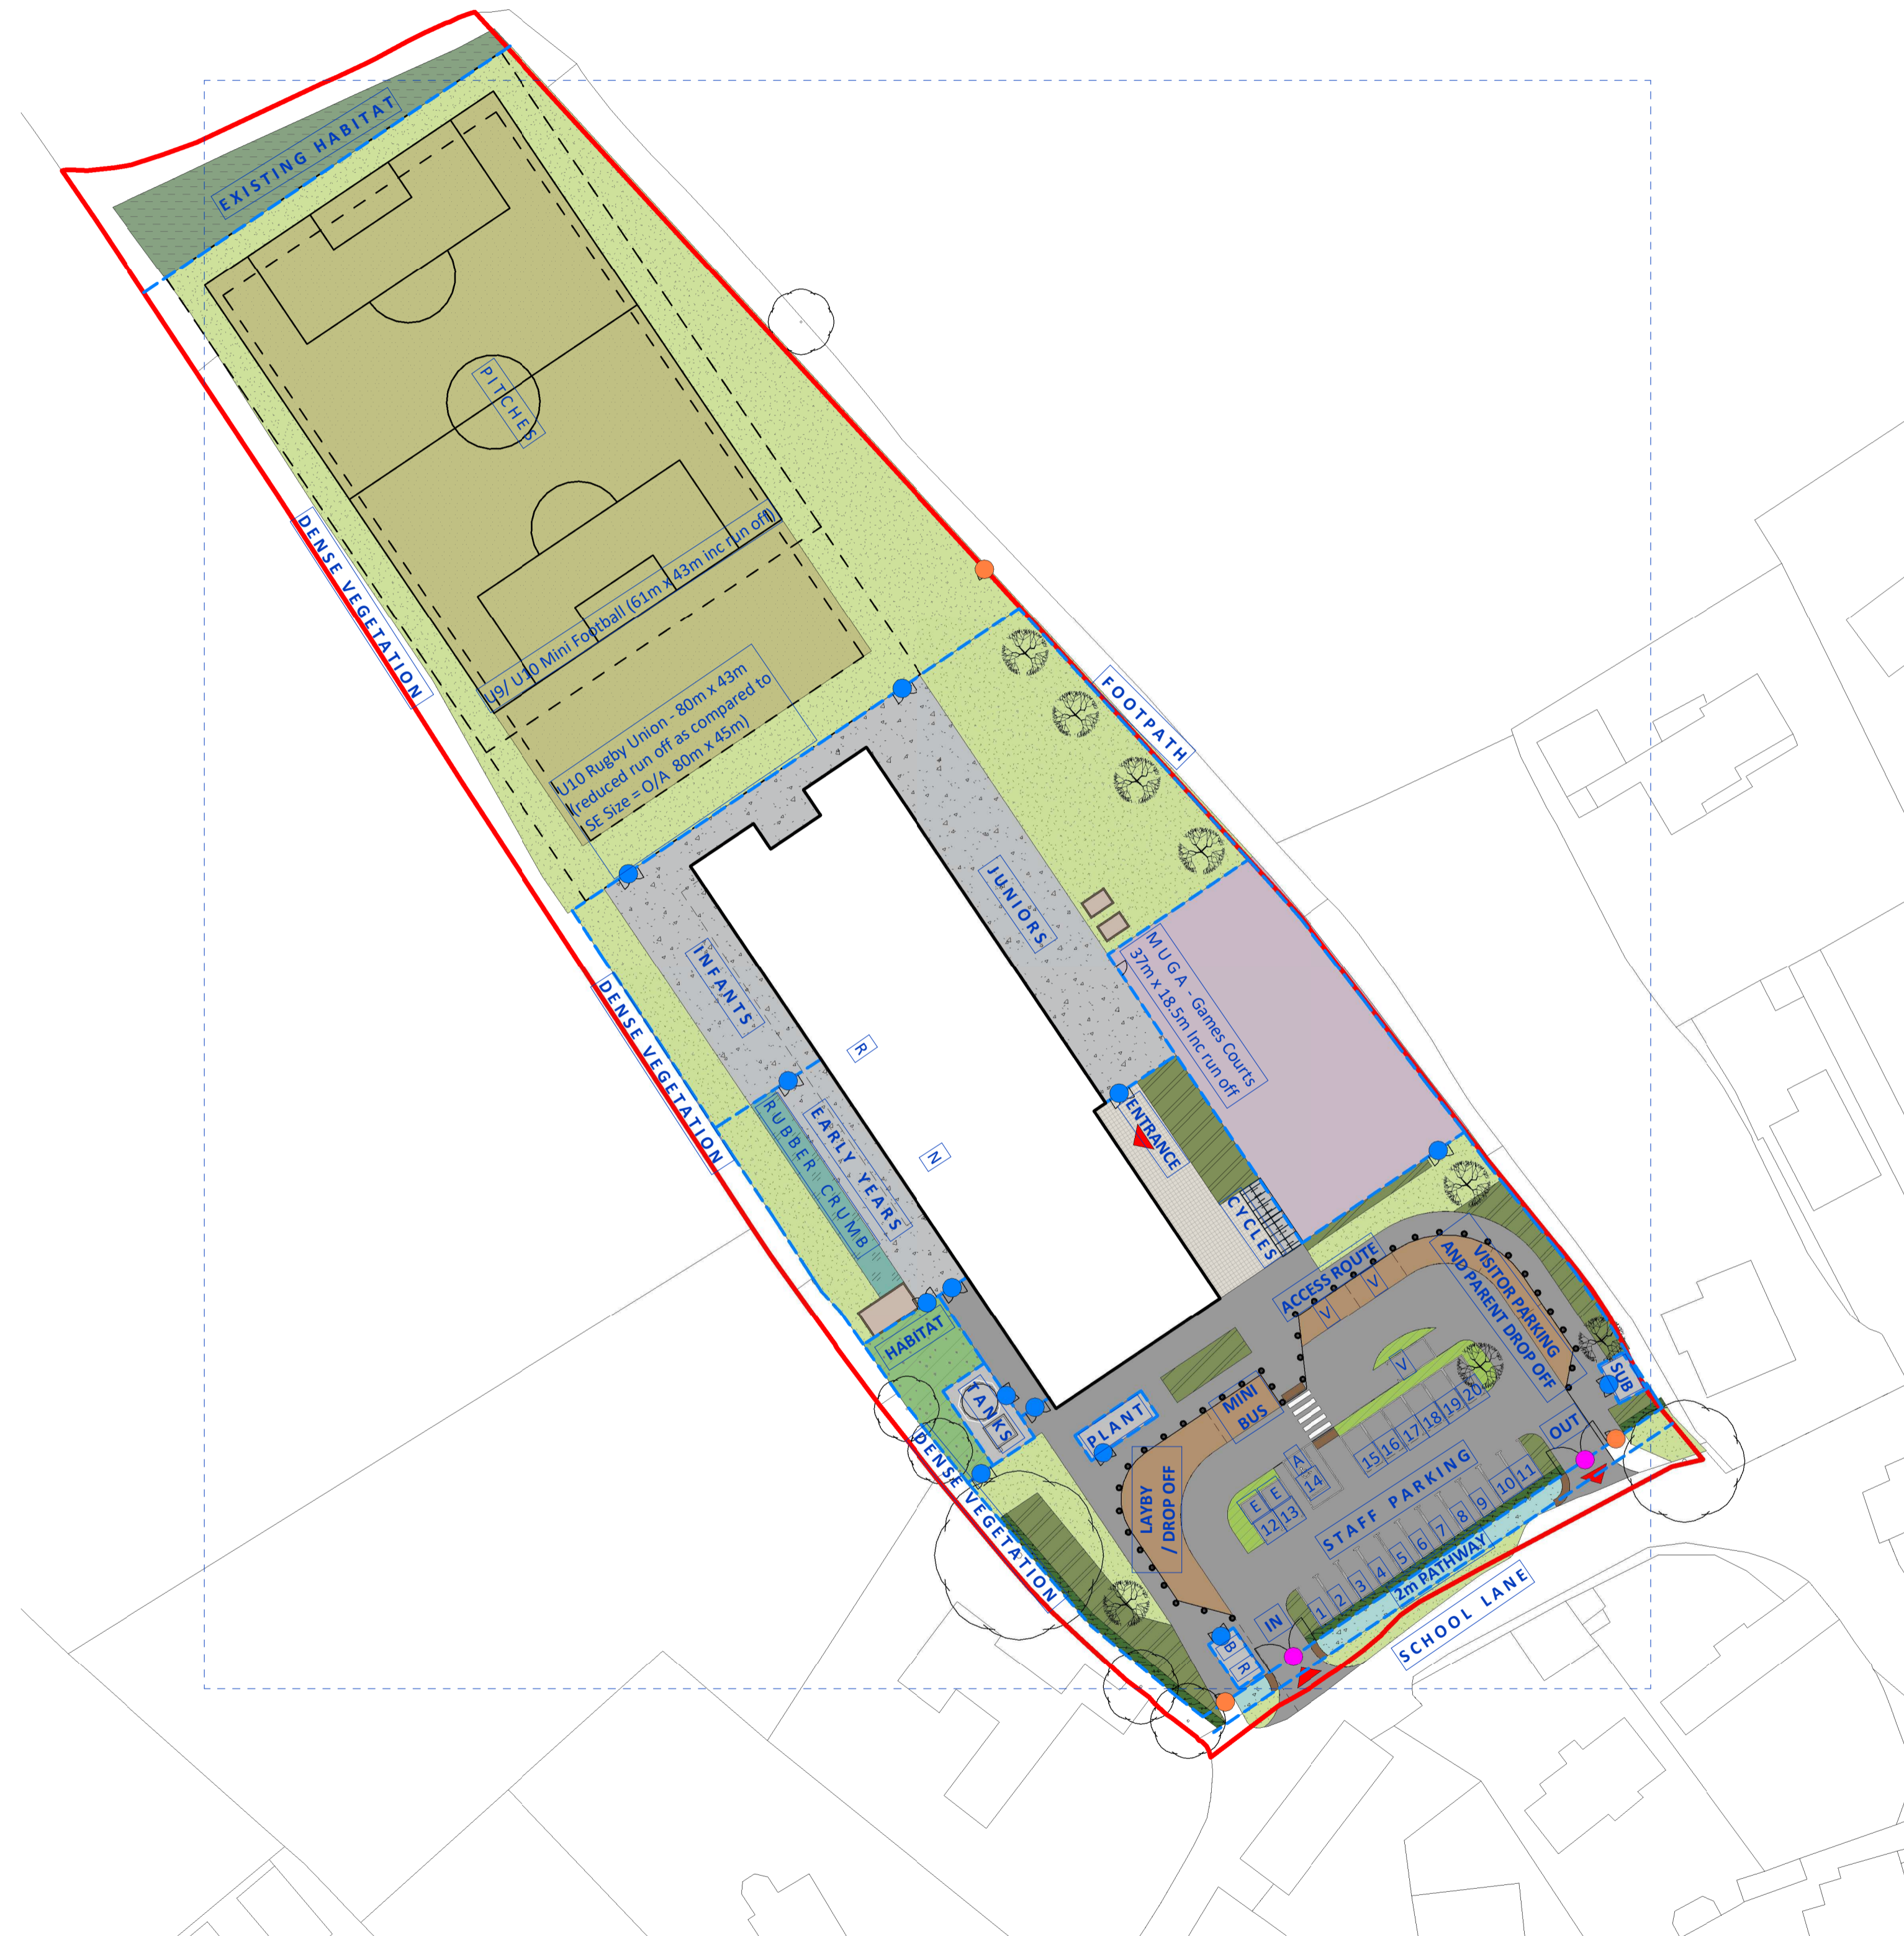

General Arrangement Plan
1 : 500

STATUS	REV	DATE	DESCRIPTION
PL	PL07	30/09/20	Updated anotation and planting for planning
PL	PL06	17/09/20	Highways input update for discharge of conditions
PL	PL05	13/09/20	For discharge of conditions
PL	PL04	09/09/20	Amended for Planning Issue
PL	PL01	07/09/20	For Stage 3 Issue
S4	P01	07/09/20	For Stage 3 Issue
PL	PL03	25/06/20	For Planning
PL	PL02	15/06/20	PAC Submission
PL	PL01	12/06/20	PAC Submission

CLIENT	REVISD BY
Vale of Glamorgan Council	CCM
CHECKED BY	CS
ORIGINATOR NO	152853

CONSULTANT
STRIDE TREGLOWN
www.stridetreglown.com © Stride Treglown Limited 2020
PROJECT
St Nicholas Primary School

DRAWING TITLE
General Arrangement Plan

STATUS CODE
PL : Authorized and accepted
SCALE
1 : 500@A1

DRAWING USAGE:
PROJECT - ORIGINATOR - VOLUME - LEVEL - TYPE - ROLE - CLASS - NUMBER
SNPS-STL-XX-XX-DR-L-9001
STATUS_REVISION
PL_PL07