

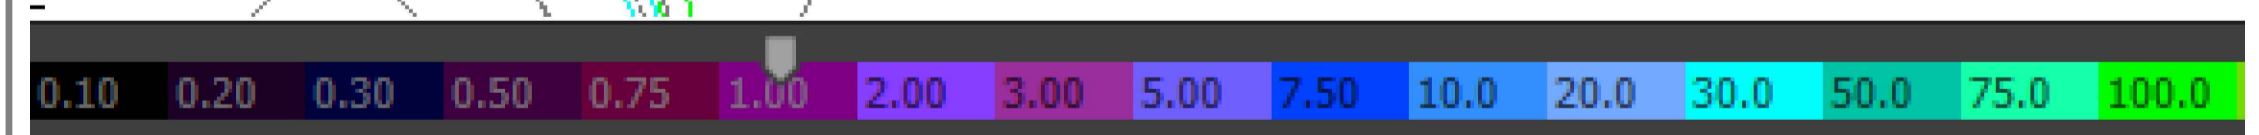


DO NOT SCALE this drawing or the computer digital data.
 Lead Consultant to be notified of any discrepancies in figured dimensions.
 Contractors must check all site dimensions.
 This drawing is copyright and is for use on this site only.
 This Drawing shall be used for pricing purposes and to highlight extent of works only. This drawing shall not be used for installation purposes. Contractor shall provide their own co-ordinated working drawings prior to start on site.

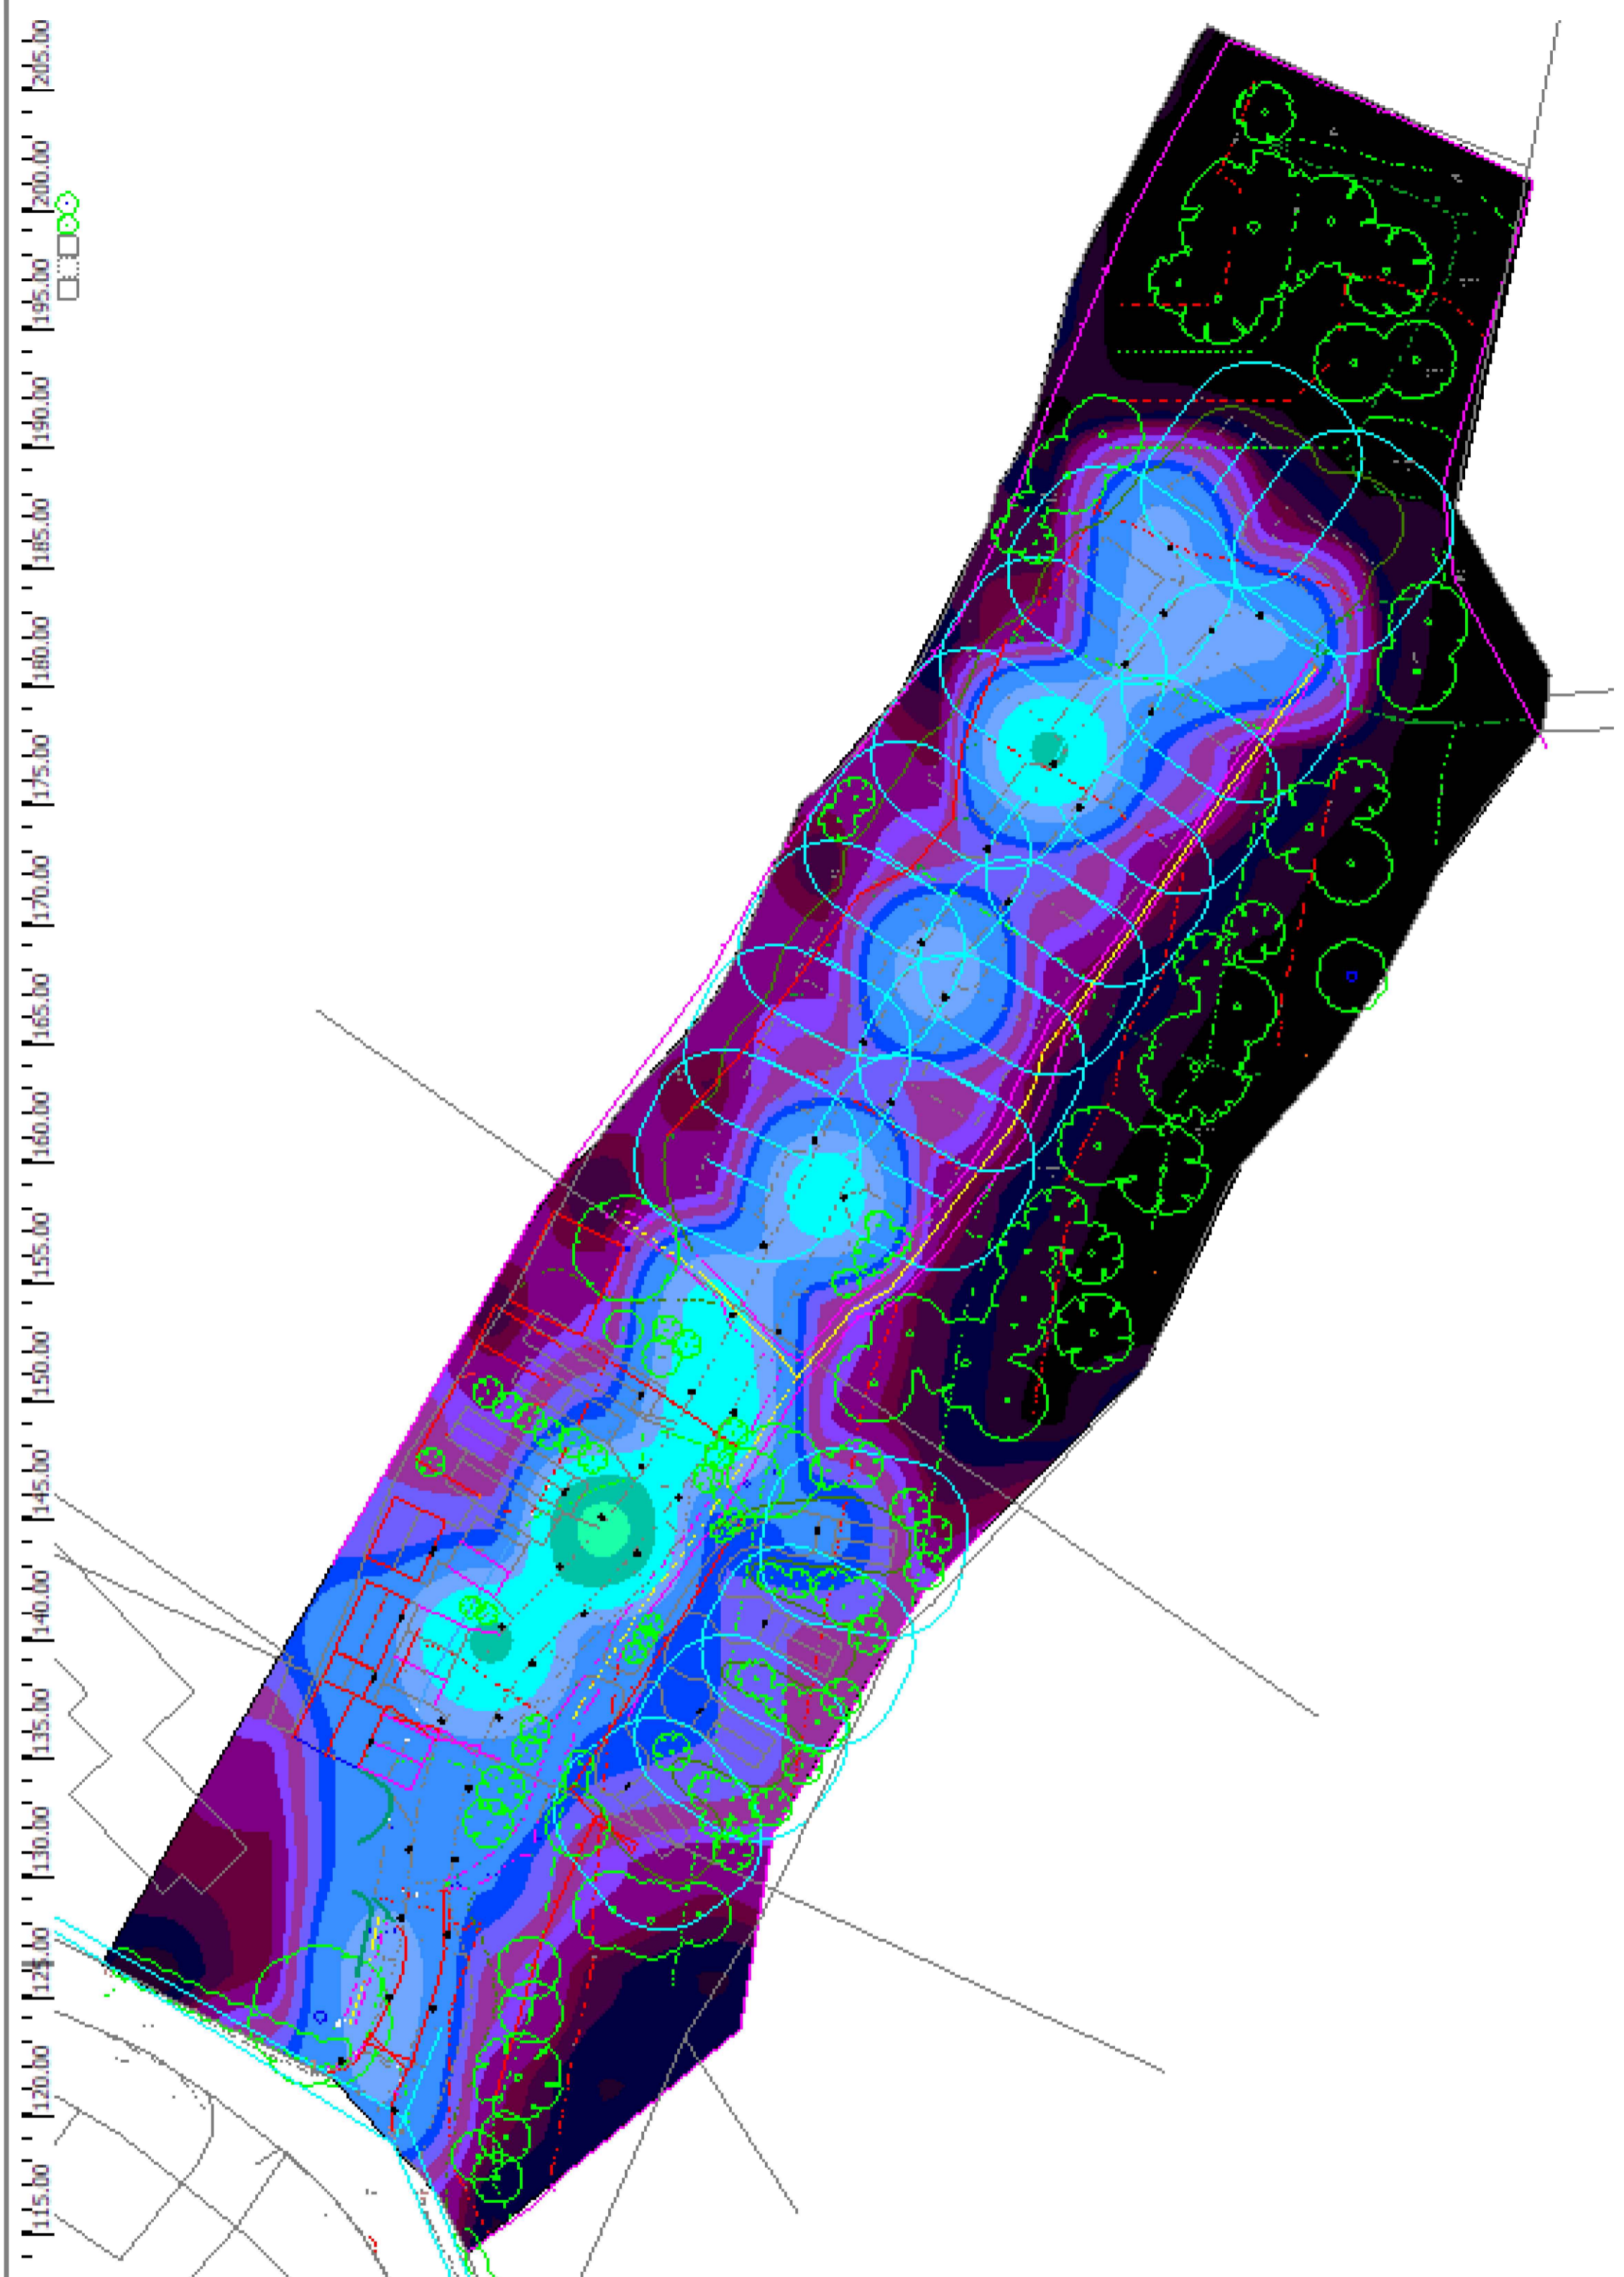

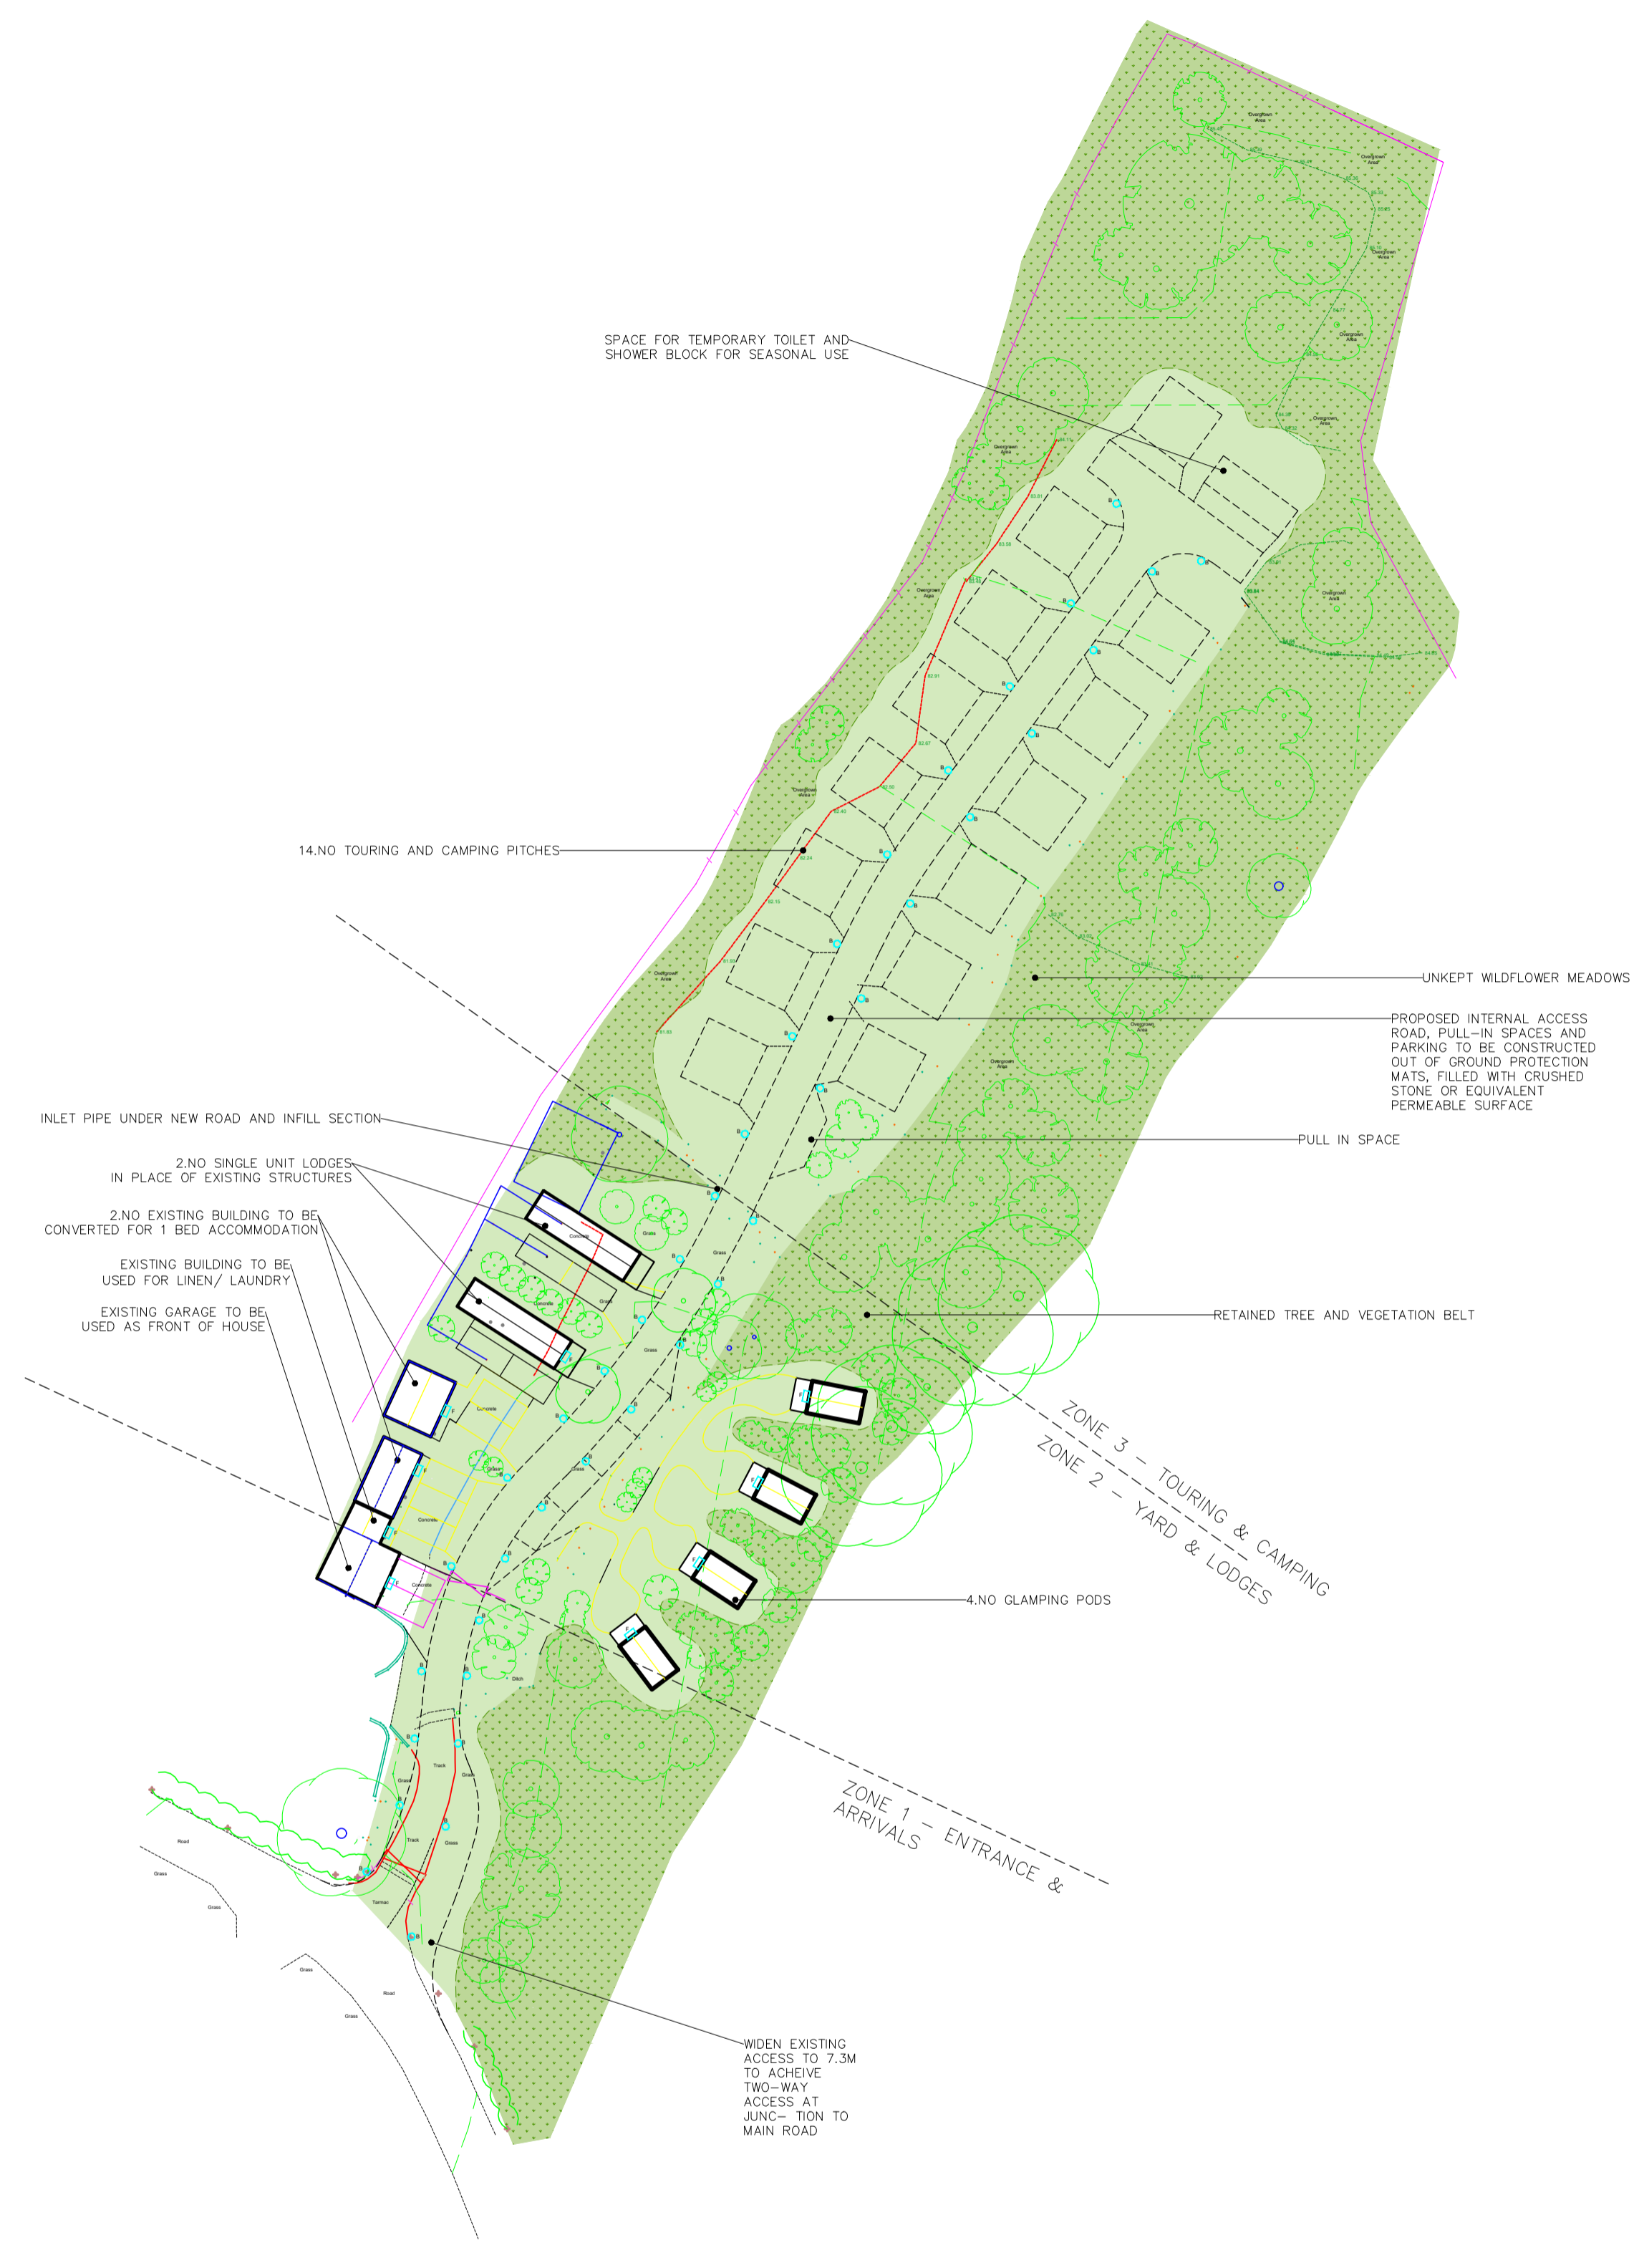

Wild Rose Cottage Site Plan

7.31 lx 0.002



- Legend**
- B 14W, 583 lumens, 4000k bollard fitting LED. As Thorn Lighting D-CO LED Bollard.
 - F 17W, 614 lumens, 4000k recessed LED. As Thorn Cesar Rect.

Ref	Revision	By	Date	Chk'd	Auth
FOR INFORMATION					
Purpose of issue					
10 Pentrepeth Road Morriston, Swansea SA6 6AB Tel: 01792 792323 Fax: 01792 792339					
Client					
 Geraint John Planning					
Project					
Wild Rose Cottage					
Drawn DE	Checked WC	Authorised WC	Original Scale @ A1 1:250		
Date Feb '22	Date Feb '22	Date Feb '22			
Title					
Proposed Lighting Calculations Lux Levels and Layout					
Drawing Number 2122.015-E01					Rev 00